 









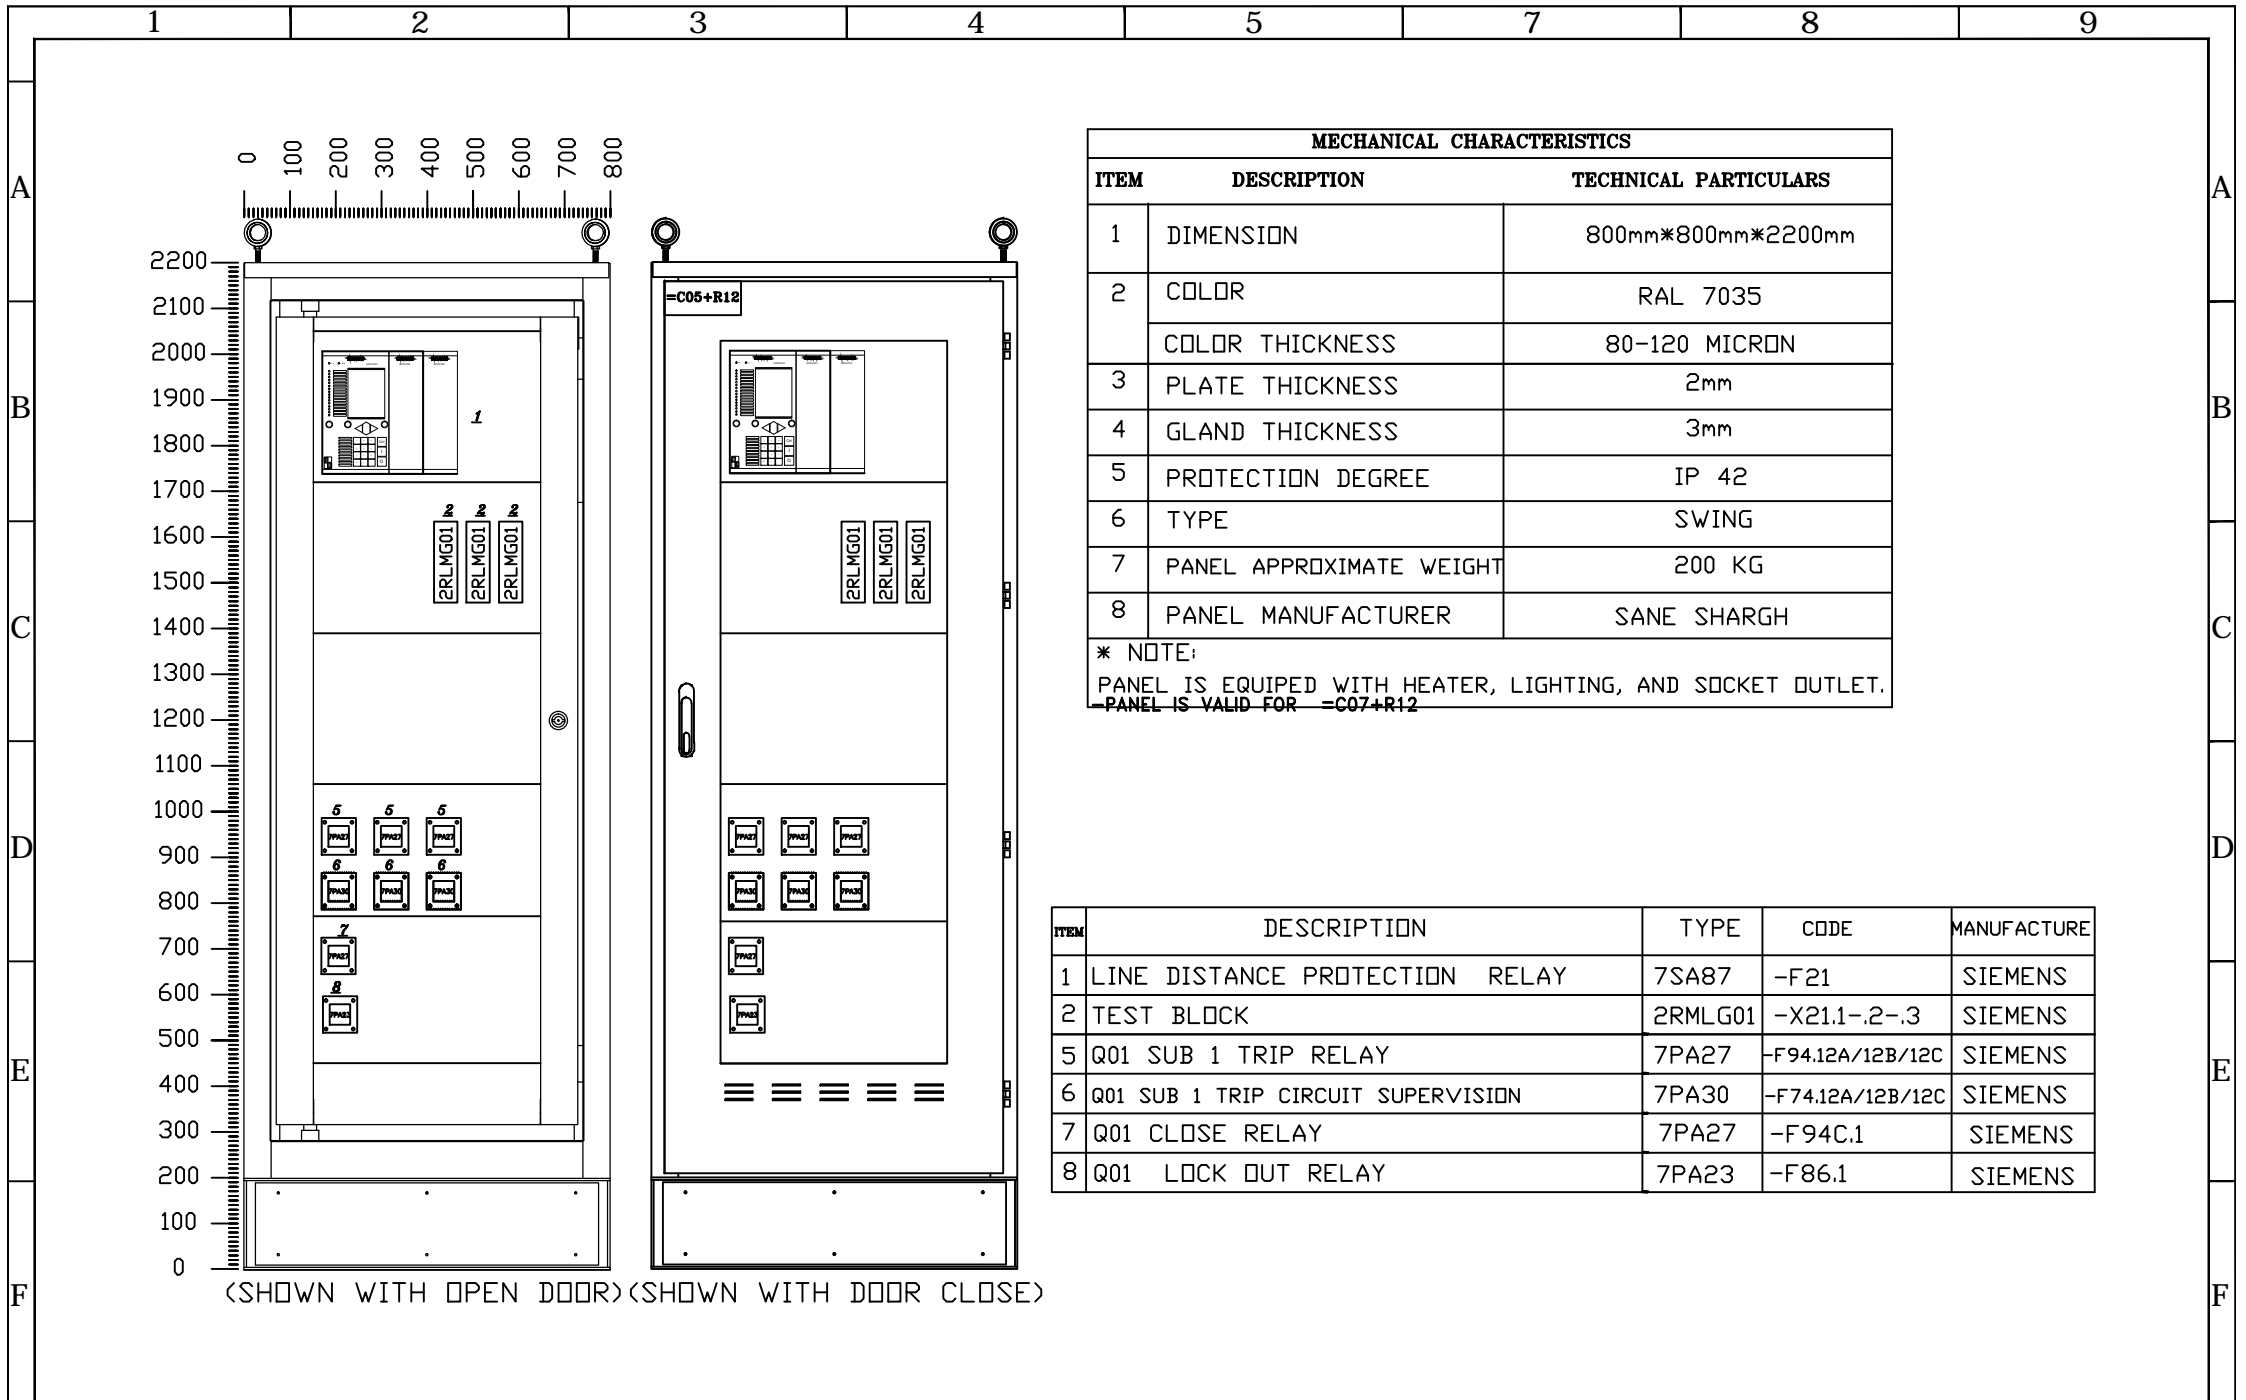
FAJR.2

400/132KV GIS SUBSTATION


PROTECTION PANELS FRONT VIEW

 



D				
C				
B				
A	SH.M		1402.06.14	FJR-MSG-MON-0036-2023/08/26
Z	SH.M		1402.05.20	FIRST ISSUE
REV.	DESIGNED	DRAWN	DATE	DESCRIPTION
		DATE:	NAME:	SCALE: -
DESIGNED		1402.05.20	SH.M	SUBJECT: FAJR.2 400/132KV GIS SUBSTATION PROTECTION FRONT VIEW
DRAWN		1402.05.20	SH.M	
CHECKED		1402.05.20	A.DEHGHAN	
APPROVED		1402.05.20	A.DEHGHAN	
CONTRACT NO: ---				DRAWING NO: MT-SUB-FJU-6275-DD-12-SJ-001
CONSULTANT:			CONTRACTOR:	CLIENT:
				
Consultant NO.:				


C			Consultant:  موننکو ایران Monenco Iran	Client:  شرکت منابع پتروشیمی خلیج فارس Persian Gulf Petrochemical Industries Co PGPIC	Contractor:  MOHAM SHARGH COMPANY		Name	Date	Title: LIST OF CONTENTS	Project: FAJR.2 400/132/KV GIS SUBSTATION PROTECTION&METERING SINGLE LINE DIAGRAM	Scale: –
B						DESIGNED	<i>SH.M</i>	<i>1402.05.20</i>			Size: A4
A	<i>FJR-MSC-MON-0036-2023/08/26</i>	<i>1402.06.14</i>				DRAWN	<i>SH.M</i>	<i>1402.05.20</i>			
Z	FIRST ISSUE	<i>1402.06.20</i>				CHECKED	<i>A.DEHGHAN</i>	<i>1402.05.20</i>		Consultant NO.: 	Sheet: 1
REV.	Description.	DATE				APPROVED	<i>A.DEHGHAN</i>	<i>1402.05.20</i>		DWG NO: MT-SUB-FJU-6275-DD-12-SJ-001 Contract No:	Next Sheet: 2

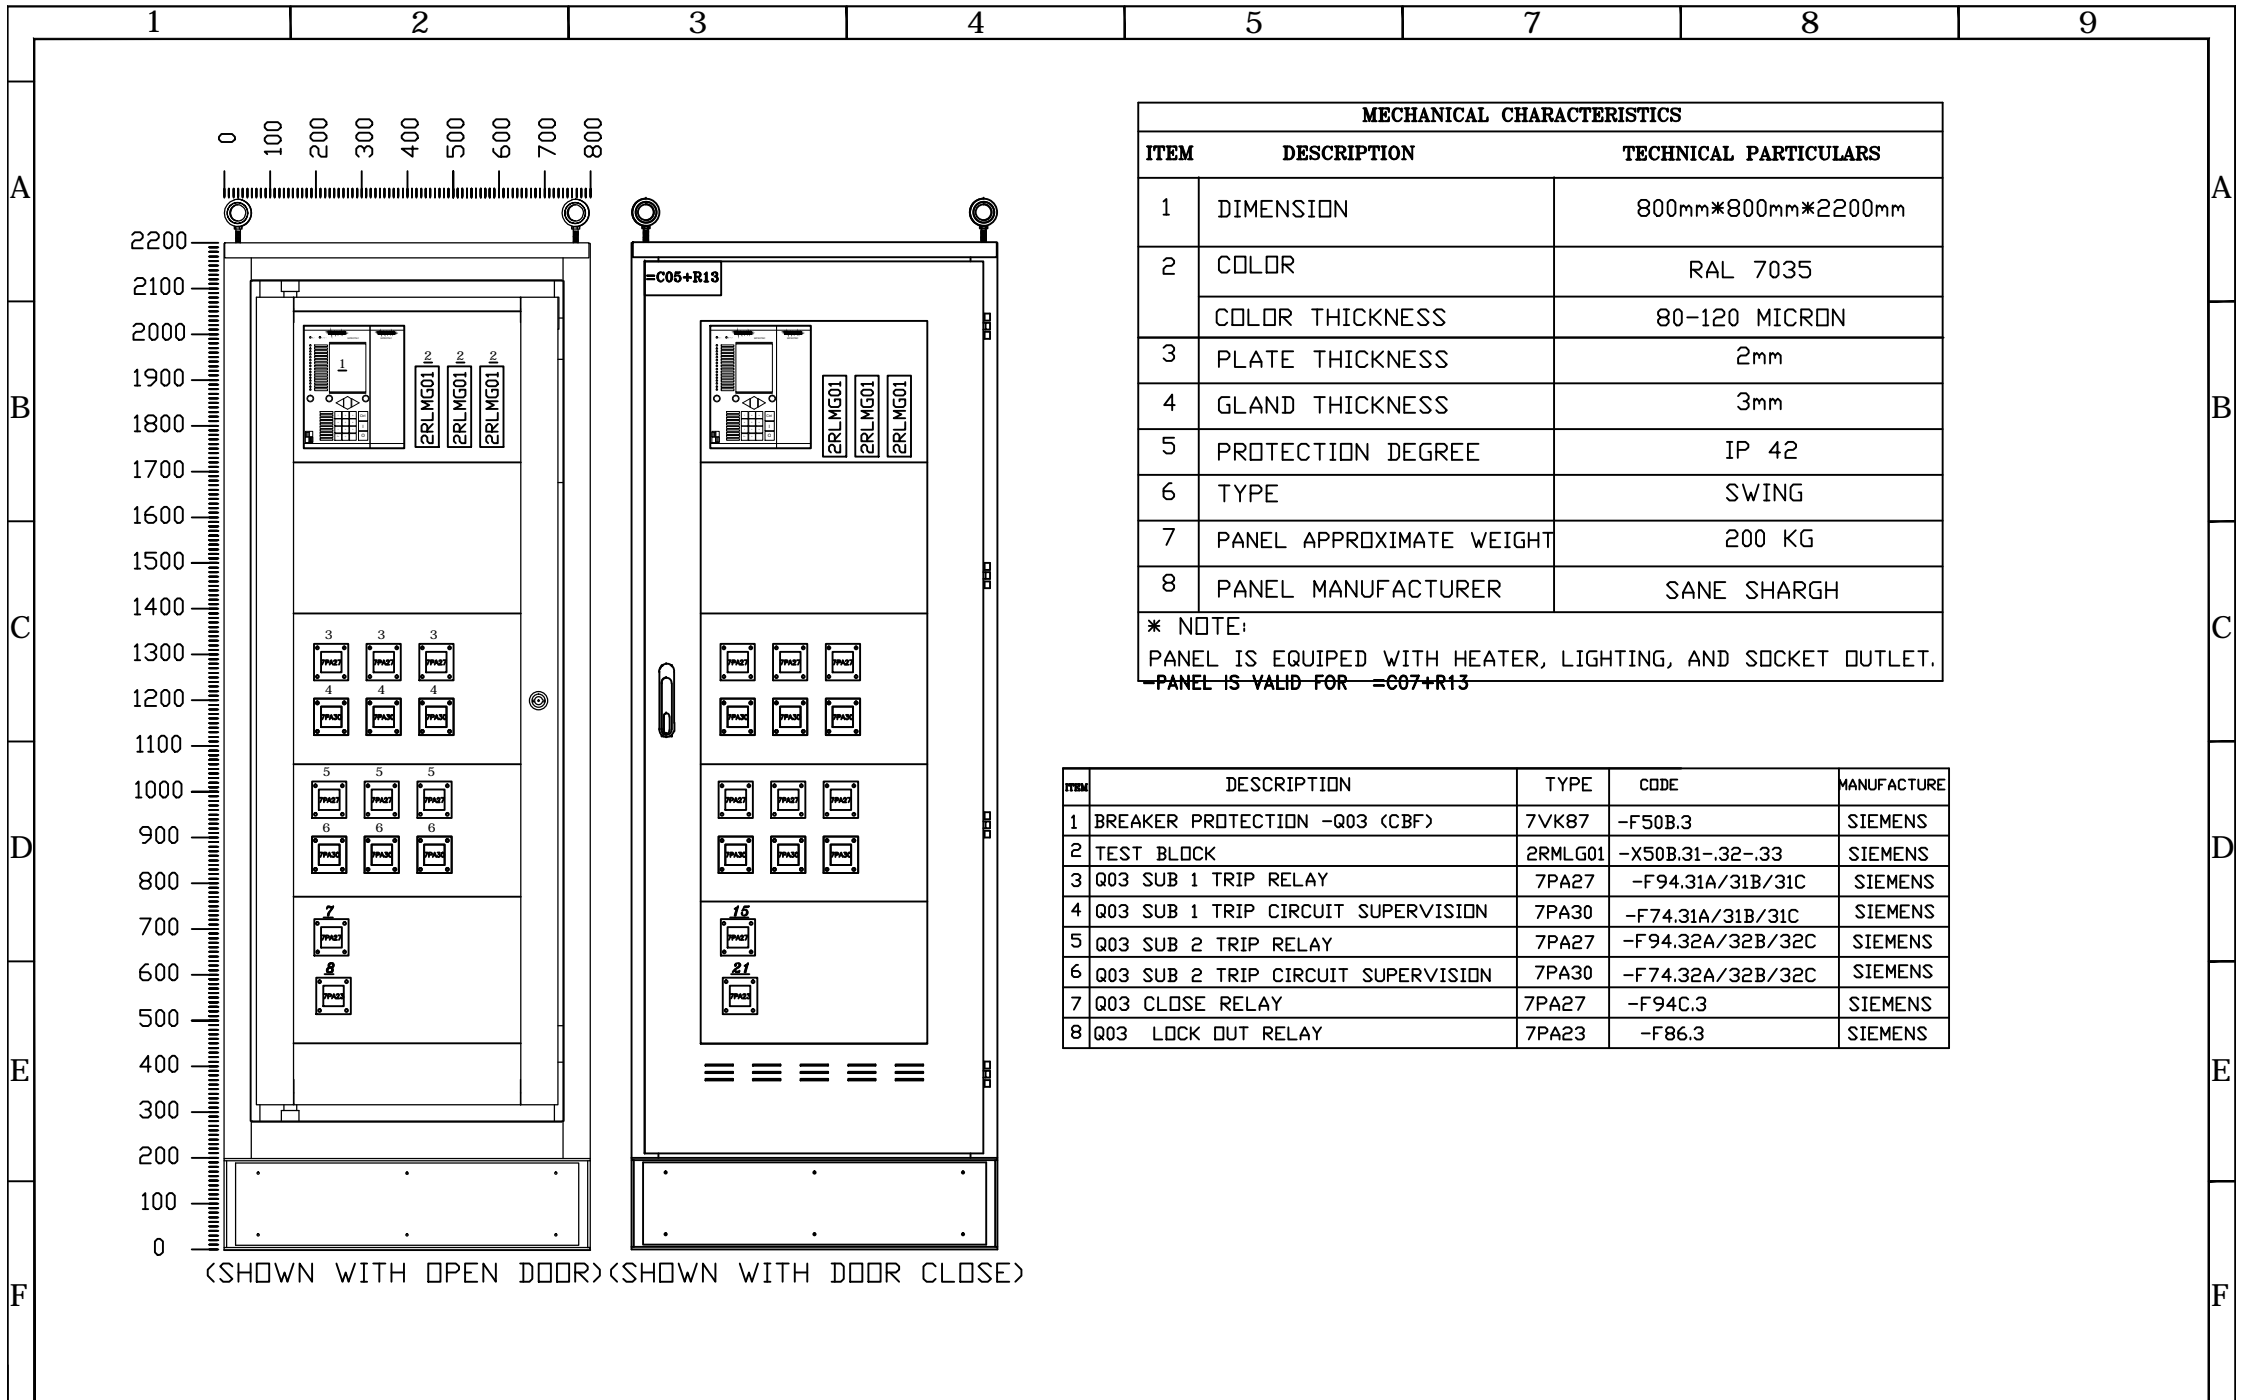


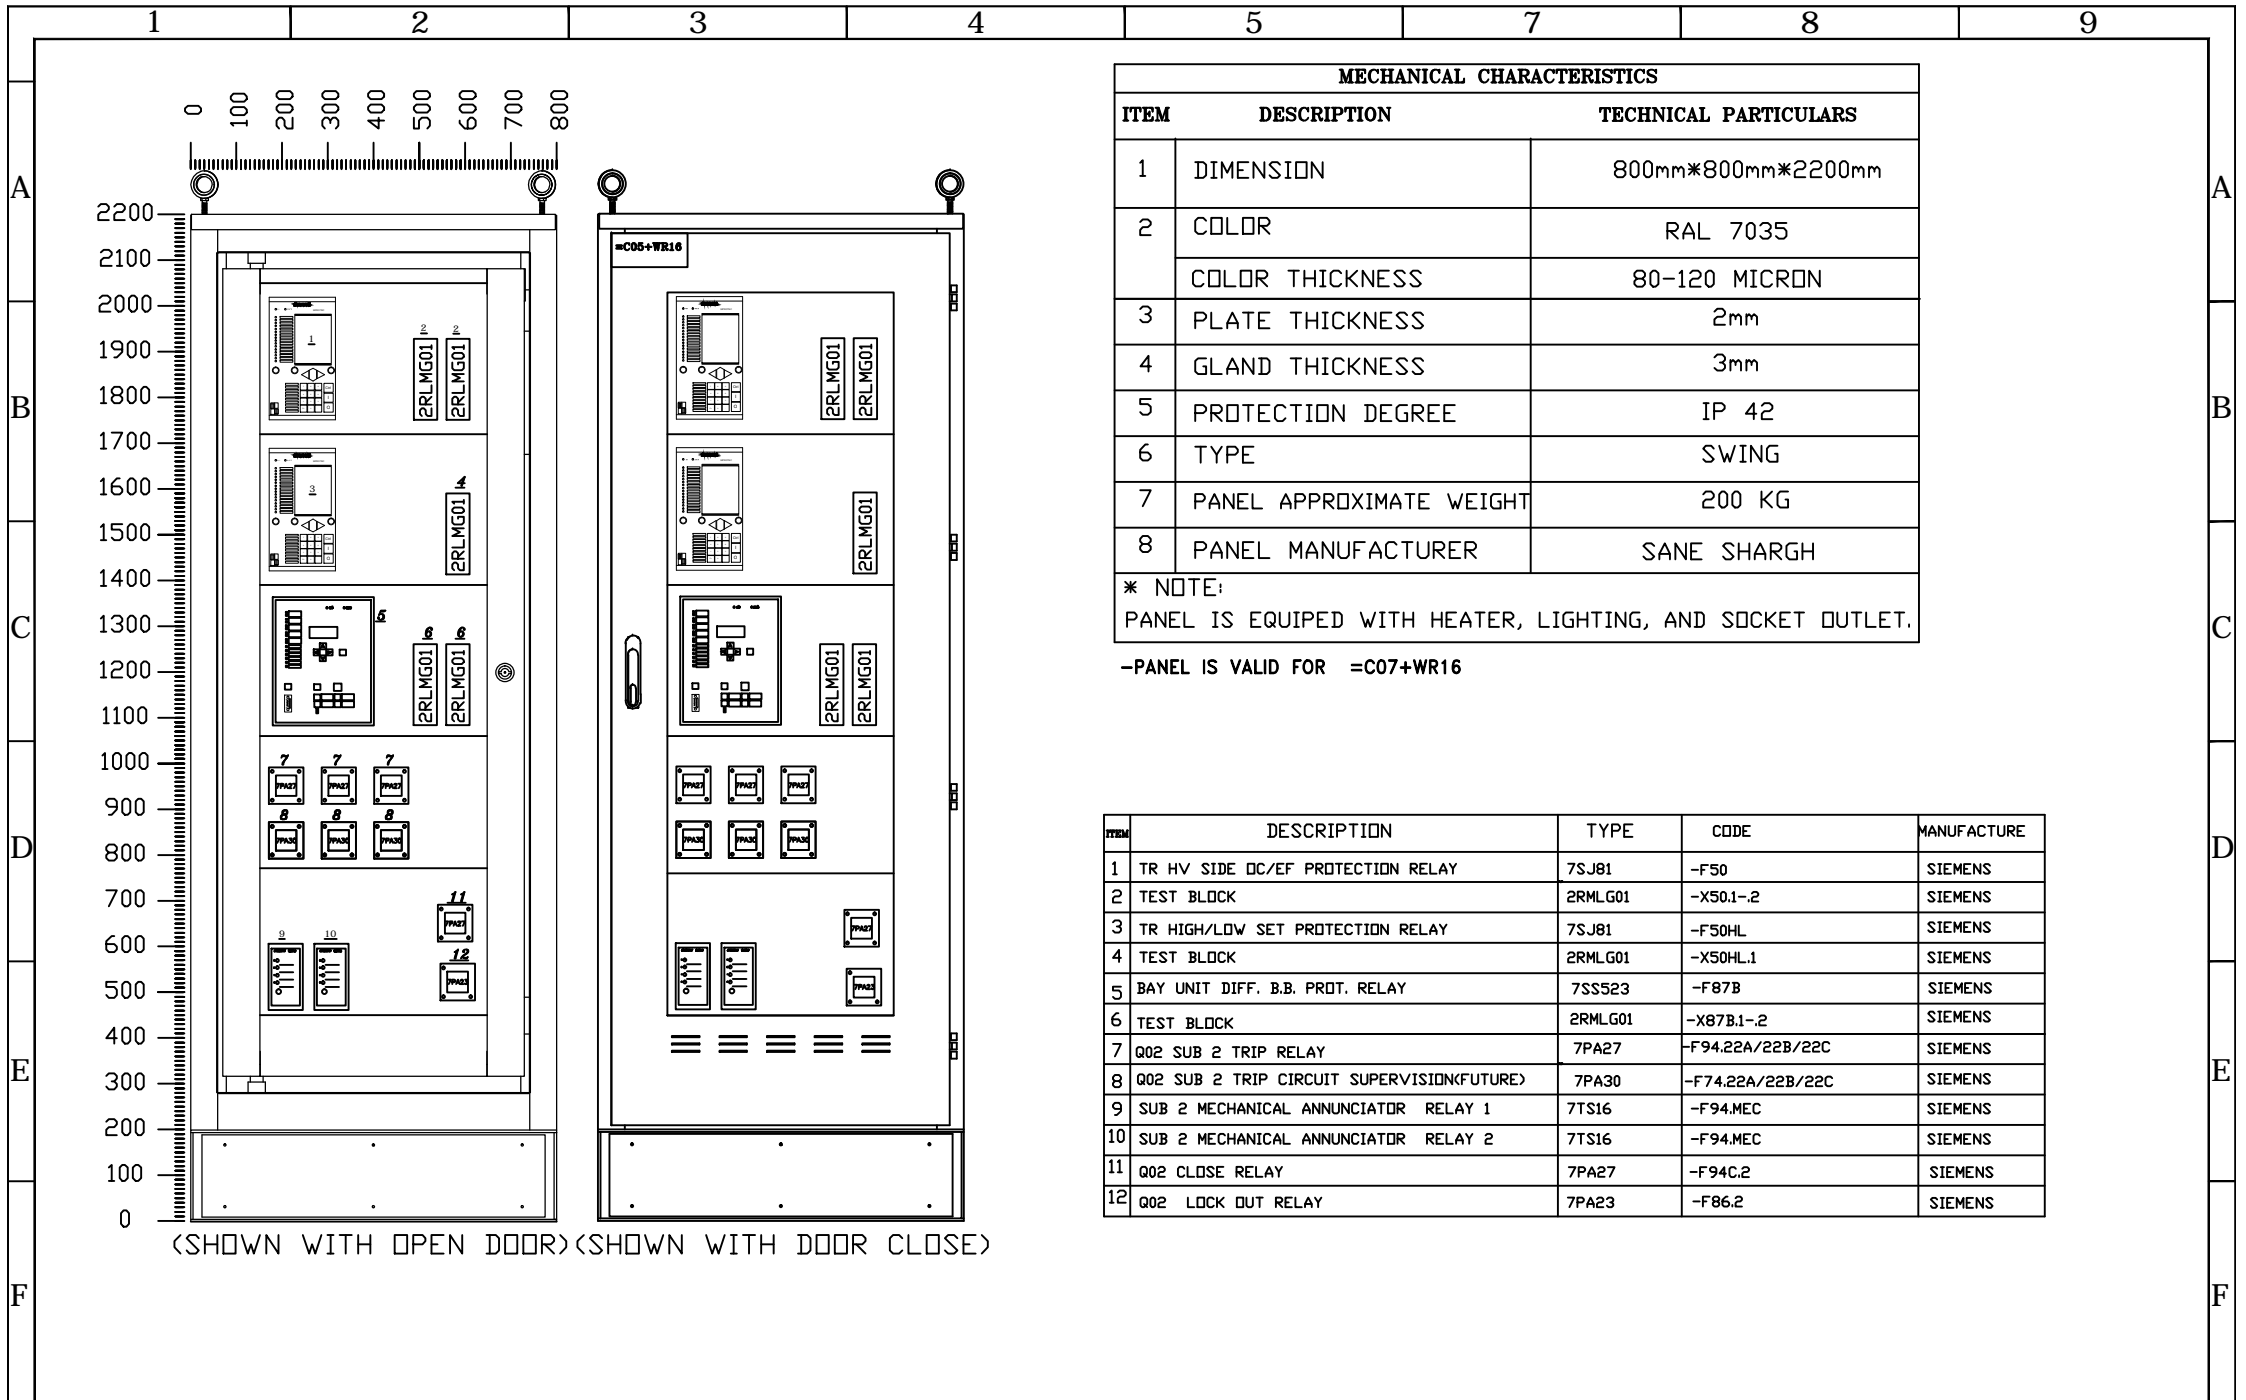
C			Consultant:	Client:	Contractor:		Name	Date	Title:	Project:	Scale: -
B							DESIGNED	SH.M	1402.05.20	400/132/KV GIS SUBSTATION	Size: A4
A	FJR-MSC-MON-0036-2023/08/26	1402.08.14					DRAWN	SH.M	1402.05.20	PROTECTION&METERING SINGLE LINE DIAGRAM	
Z	FIRST ISSUE	1402.05.20					CHECKED	A.DEHCHAN	1402.05.20	Consultant NO.:	Sheet: 3
REV.	Description.	DATE					APPROVED	A.DEHCHAN	1402.05.20	Contract No:	Next Sheet: 4





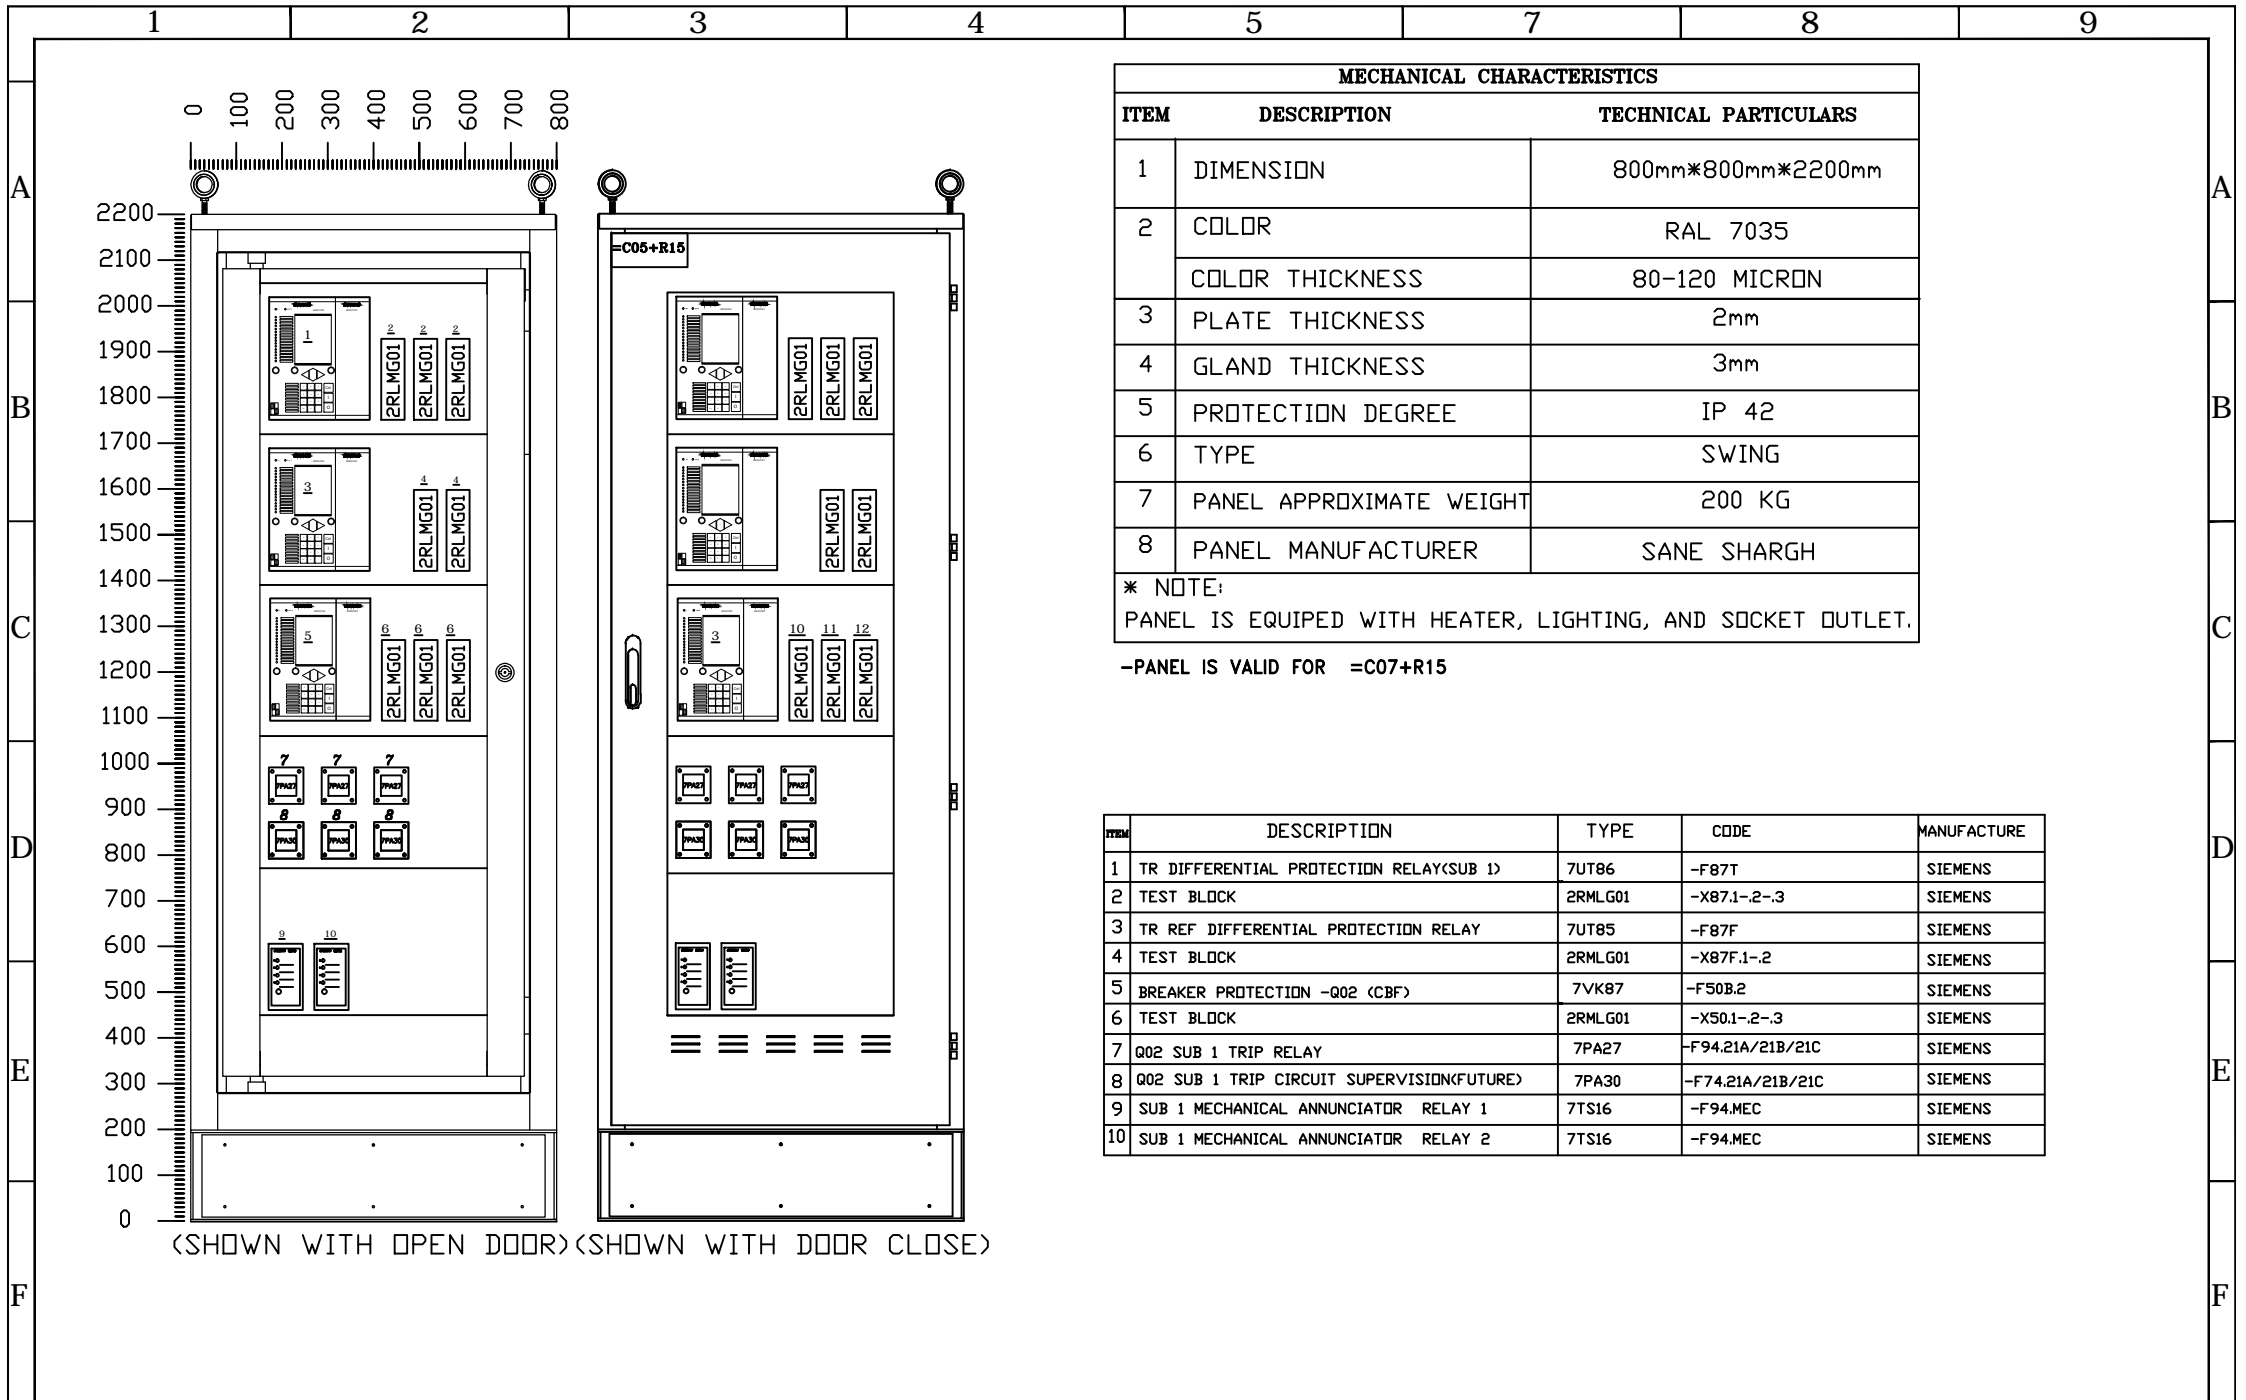


C			Consultant:	Client:	Contractor:		Name	Date	Title:	Project:	Scale: -
B							DESIGNED	SH.M	1402.05.20	400/132/KV GIS SUBSTATION	Size: A4
A	FJR-MSC-MON-0036-2023/08/26	1402.06.14					DRAWN	SH.M	1402.05.20	PROTECTION PANEL (=C05+R13) FRONT VIEW	PROTECTION&METERING SINGLE LINE DIAGRAM
Z	FIRST ISSUE	1402.05.20					CHECKED	A.DEHCHAN	1402.05.20	Consultant NO.:	Sheet: 4
REV.	Description.	DATE					APPROVED	A.DEHCHAN	1402.05.20	Contract No:	Next Sheet: 5




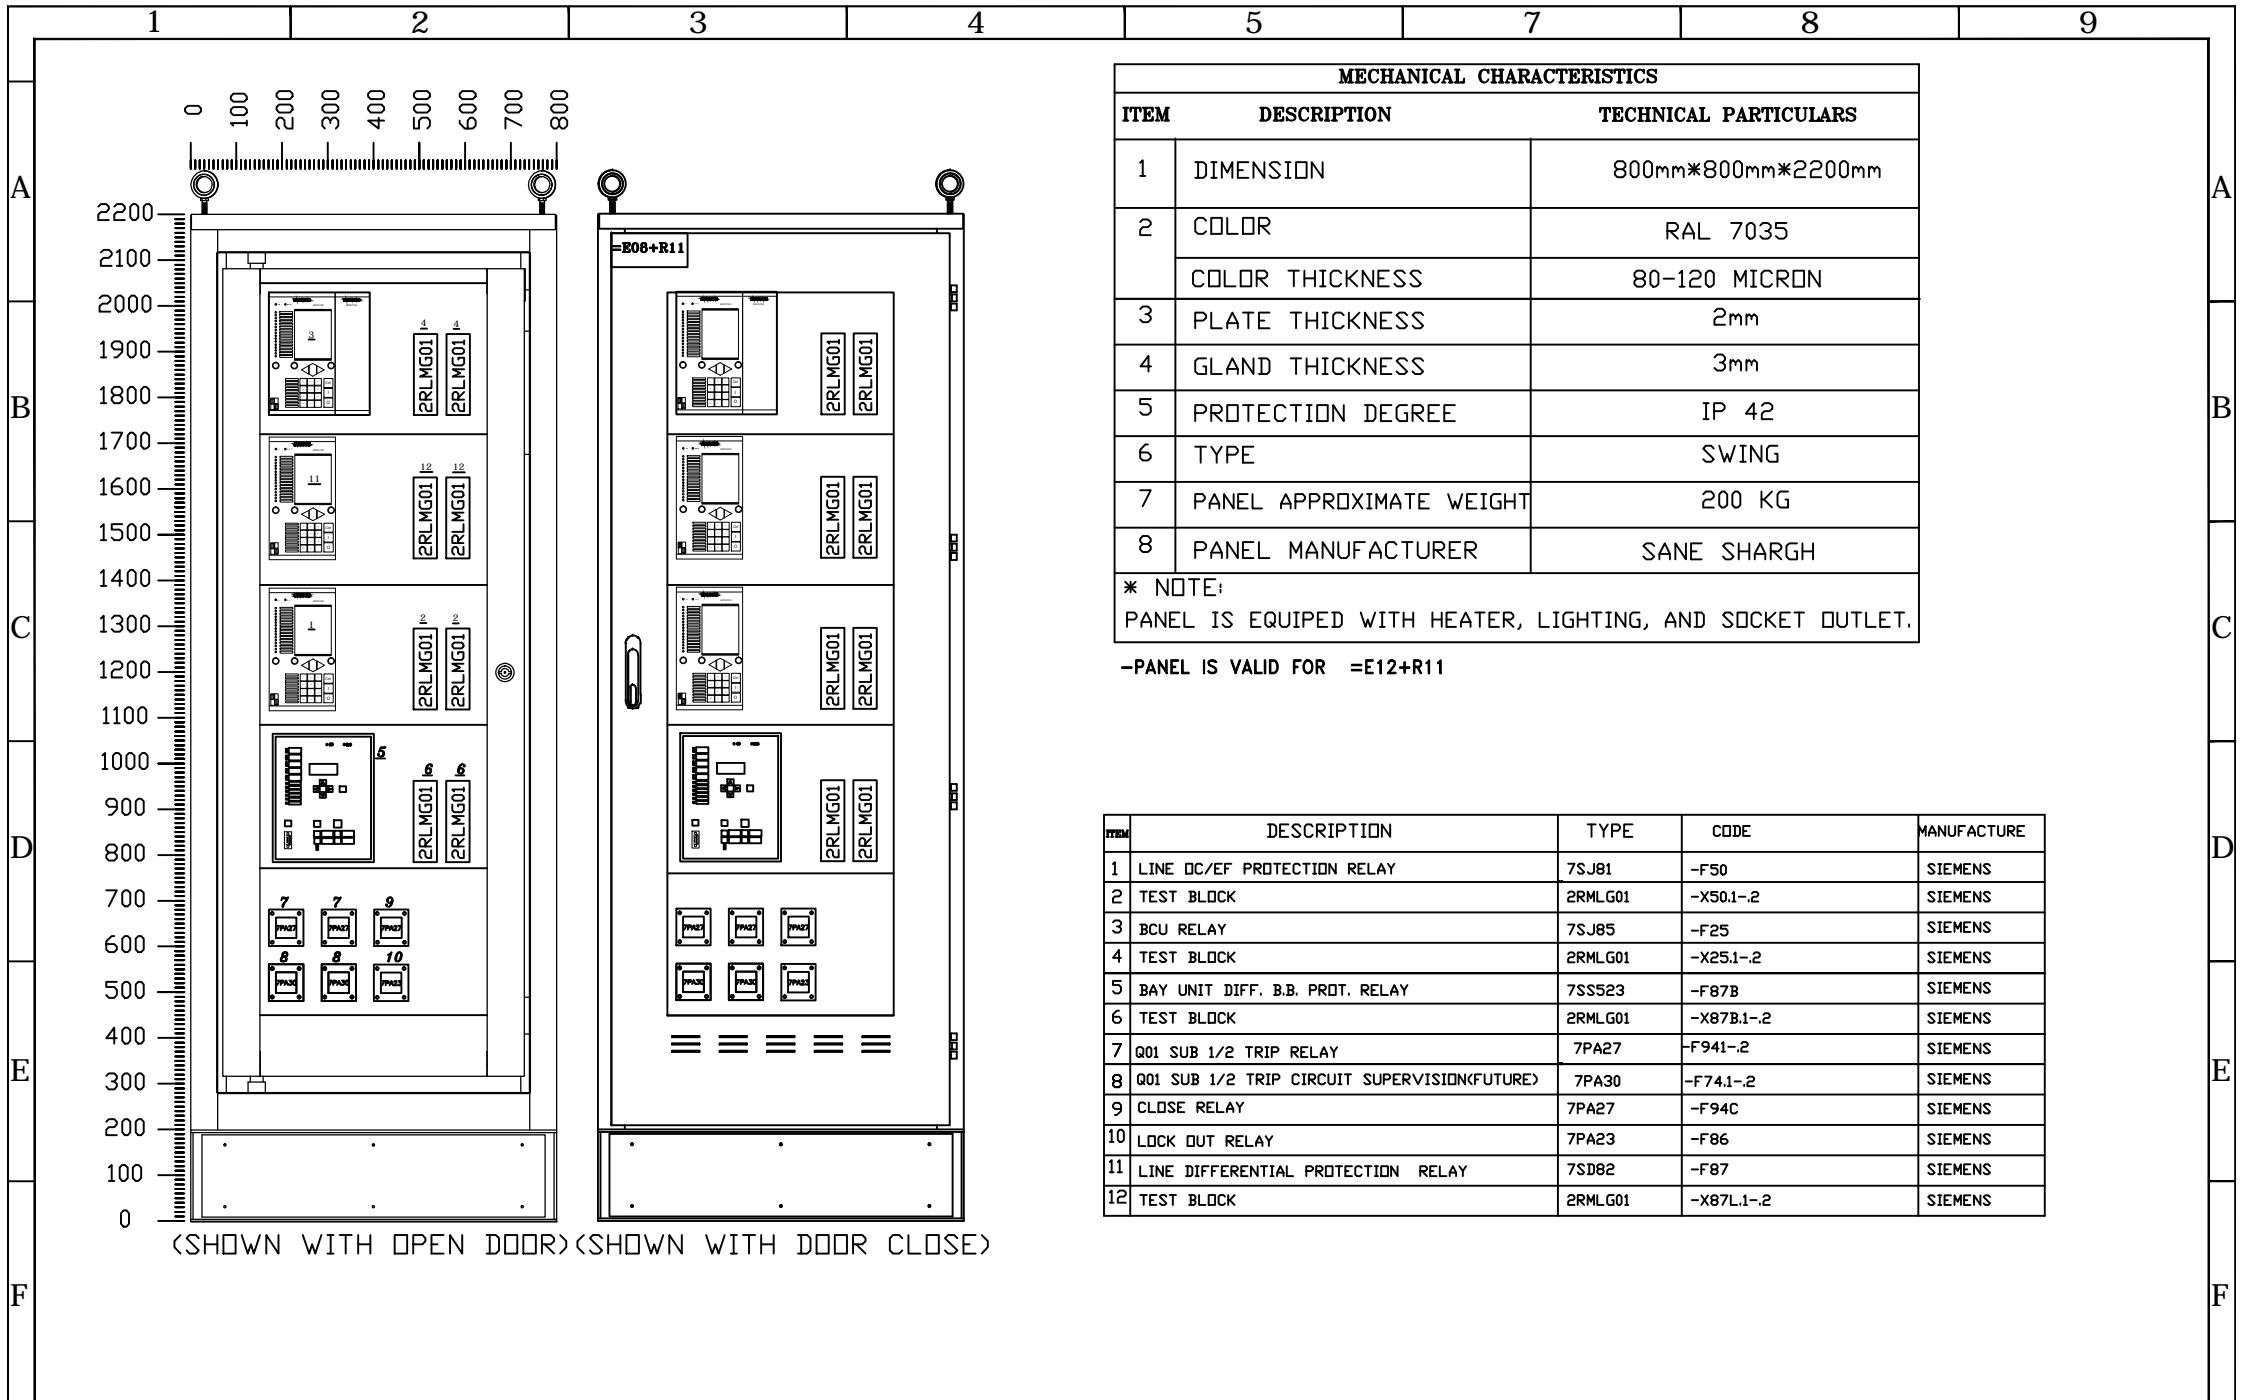
C			Consultant:	Client:	Contractor:		Name	Date	Title:	Project:	Scale: -
B							DESIGNED	SH.M	1402.05.20	FAJR.2	
A	FJR-MSC-MON-0036-2023/08/26	1402.06.14					DRAWN	SH.M	1402.05.20	400/132/KV GIS SUBSTATION	Size: A4
Z	FIRST ISSUE	1402.05.20	مونسکو ایران Monenco Iran	شرکت سانه شارج Parsan Gulf Petrochemical Industries Co PGPIC	MOHAM SHARGH COMPANY		CHECKED	A.DEHCHAN	1402.05.20	PROTECTION&METERING SINGLE LINE DIAGRAM	Sheet: 6
REV.	Description.	DATE					APPROVED	A.DEHCHAN	1402.05.20	Consultant NO.:	Next Sheet: 7
									DWG NO: MT-SUB-FJU-6275-DD-12-SJ-001	Contract No:	




C			Consultant:  مونenco ایران Monenco Iran	 شرکت سانه شارج پارس Parsan Gulf Petrochemical Industries Co PGPIC	 MOHAM SHARGH COMPANY		Name	Date	Title: PROTECTION PANEL (=C05+WR16) FRONT VIEW	Project: FAJR.2 400/132/KV GIS SUBSTATION PROTECTION&METERING SINGLE LINE DIAGRAM	Scale: -
B						DESIGNED	SH.M	1402.05.20			Size: A4
A	FJR-MSC-MON-0036-2023/08/26	1402.06.14				DRAWN	SH.M	1402.05.20			
Z	FIRST ISSUE	1402.05.20				CHECKED	A.DEHCHAN	1402.05.20			
REV.	Description.	DATE									APPROVED

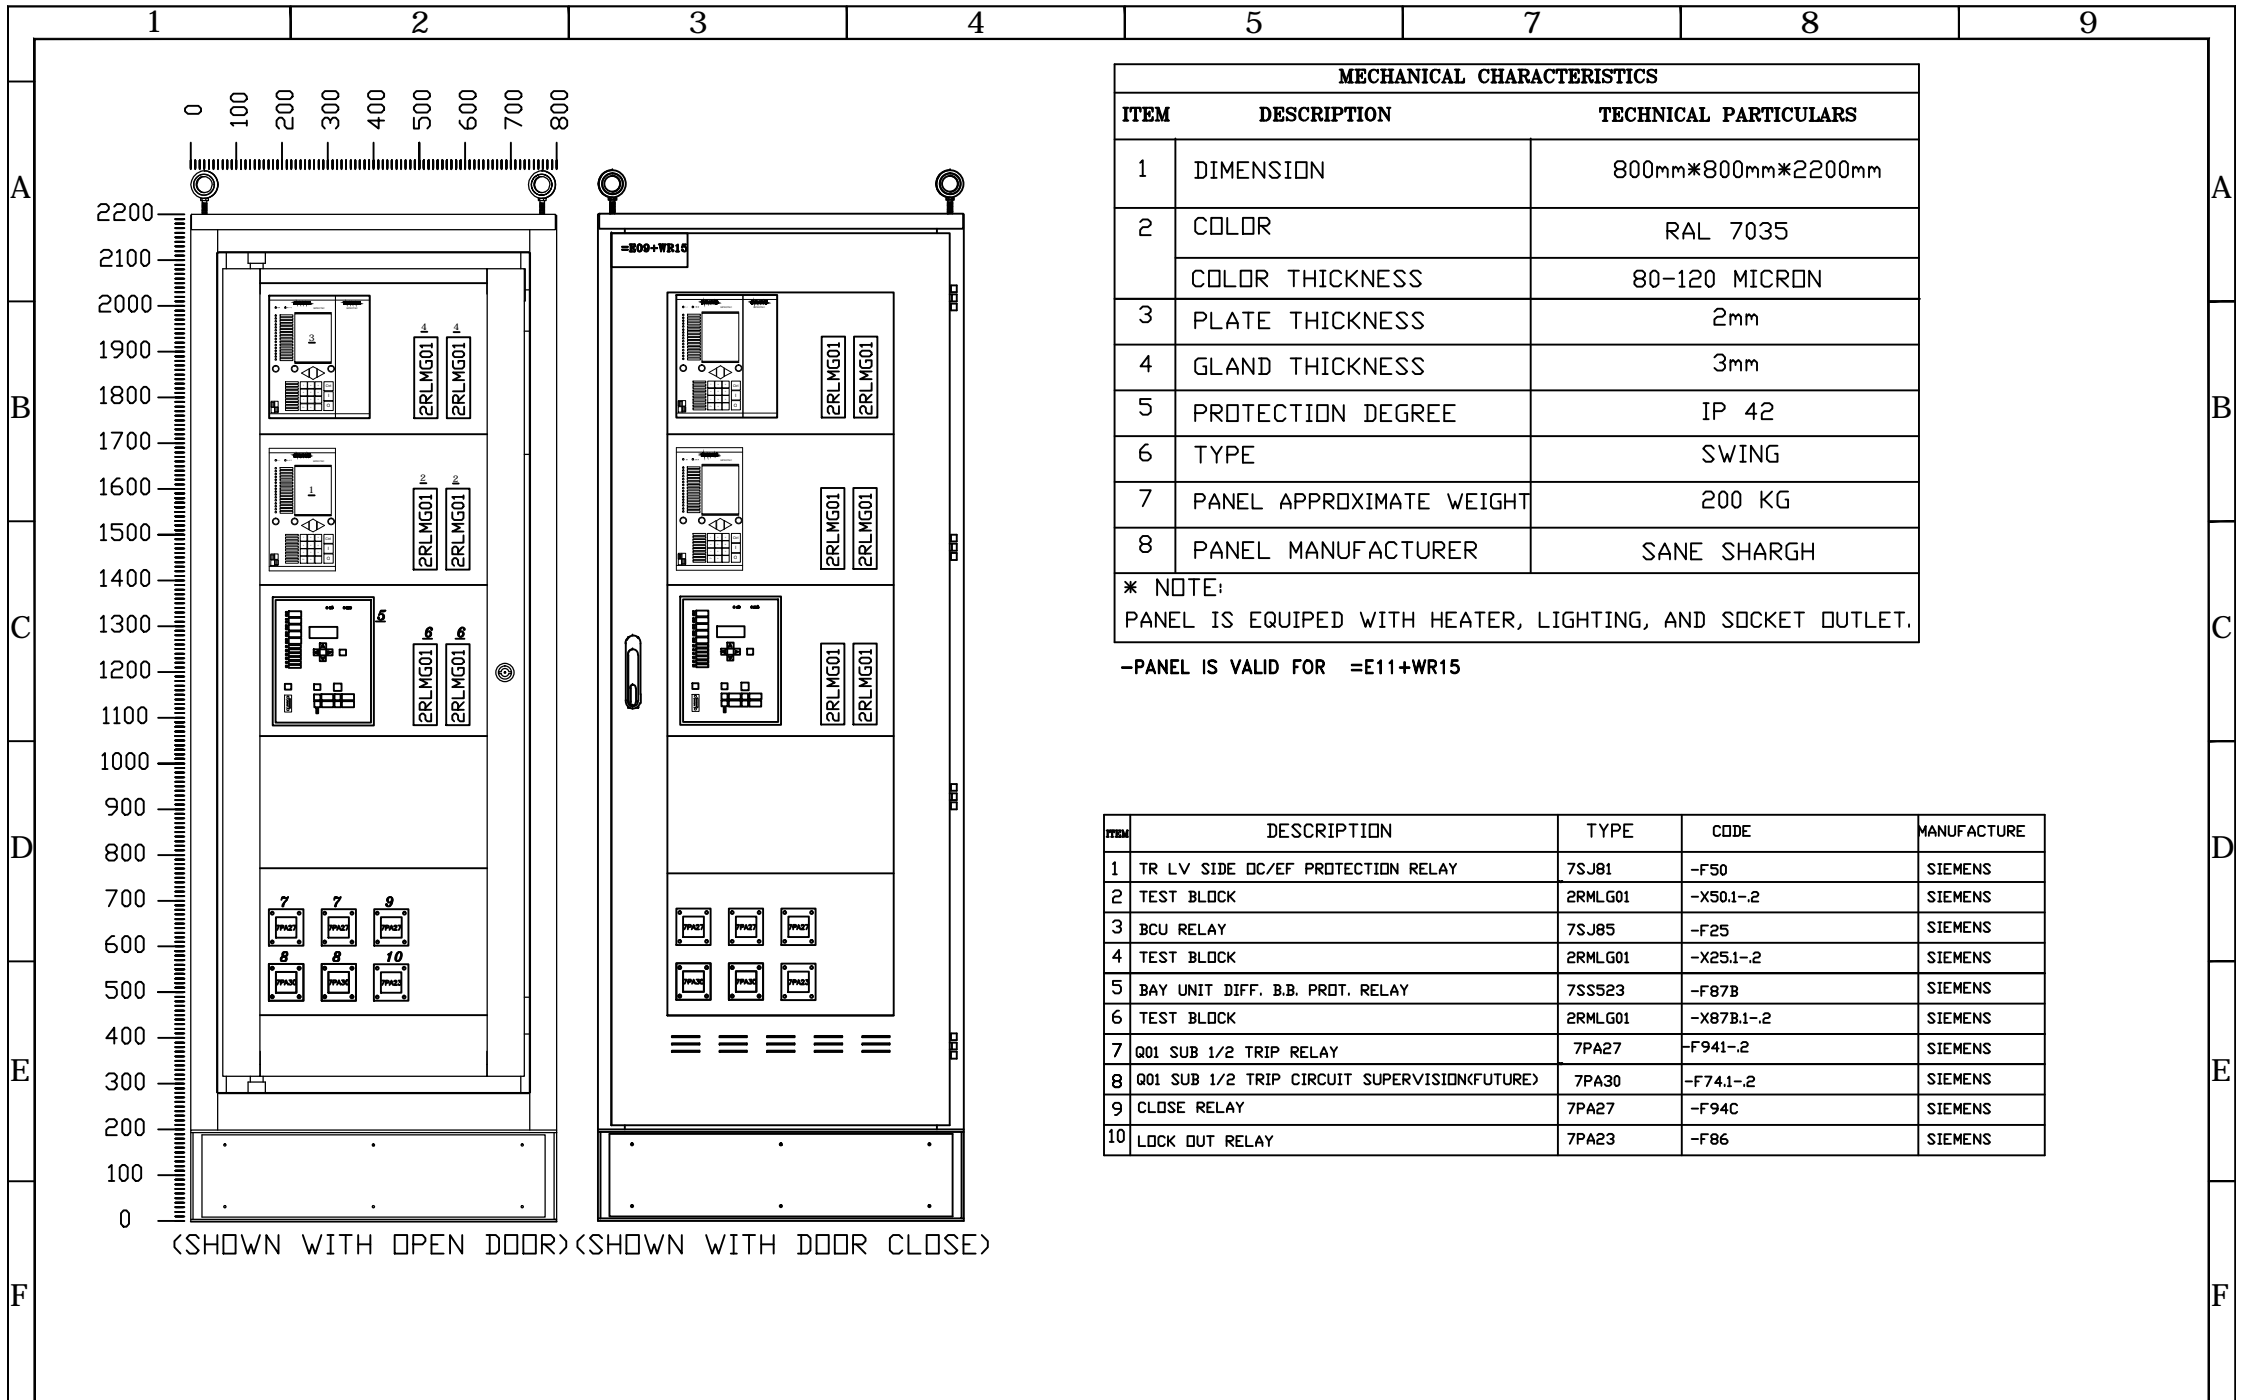


C			Consultant:	Client:	Contractor:		Name	Date	Title:	Project:	Scale: -
B						DESIGNED	SH.M	1402.05.20		FAJR.2	
A	FJR-MSC-MON-0036-2023/08/26	1402.06.14				DRAWN	SH.M	1402.05.20	PROTECTION PANEL	400/132/KV GIS SUBSTATION	Size: A4
Z	FIRST ISSUE	1402.05.20	مونسکو ایران Monenco Iran	شرکت سانه شارج Sane Shargh Company	MOHAM SHARGH COMPANY	CHECKED	A.DEHCHAN	1402.05.20	(=E09+WR15) FRONT VIEW	PROTECTION&METERING SINGLE LINE DIAGRAM	Sheet: 8
REV.	Description.	DATE				APPROVED	A.DEHCHAN	1402.05.20	DWG NO: MT-SUB-FJU-6275-DD-12-SJ-001	Contract No:	Next Sheet: 9



C			Consultant:	Client:	Contractor:		Name	Date	Title:	Project:	Scale: -
B							DESIGNED	SH.M	1402.05.20	FAJR.2	
A	FJR-MSC-MON-0036-2023/08/26	1402.06.14					DRAWN	SH.M	1402.05.20	400/132/KV GIS SUBSTATION	Size: A4
Z	FIRST ISSUE	1402.05.20	مونسکو ایران Monenco Iran	شرکت سانه شرج	MOHAM SHARGH COMPANY		CHECKED	A.DEHCHAN	1402.05.20	PROTECTION & METERING SINGLE LINE DIAGRAM	Sheet: 9
REV.	Description.	DATE					APPROVED	A.DEHCHAN	1402.05.20	Consultant NO.:	Next Sheet: 10
									DWG NO: MT-SUB-FJU-6275-DD-12-SJ-001	Contract No:	

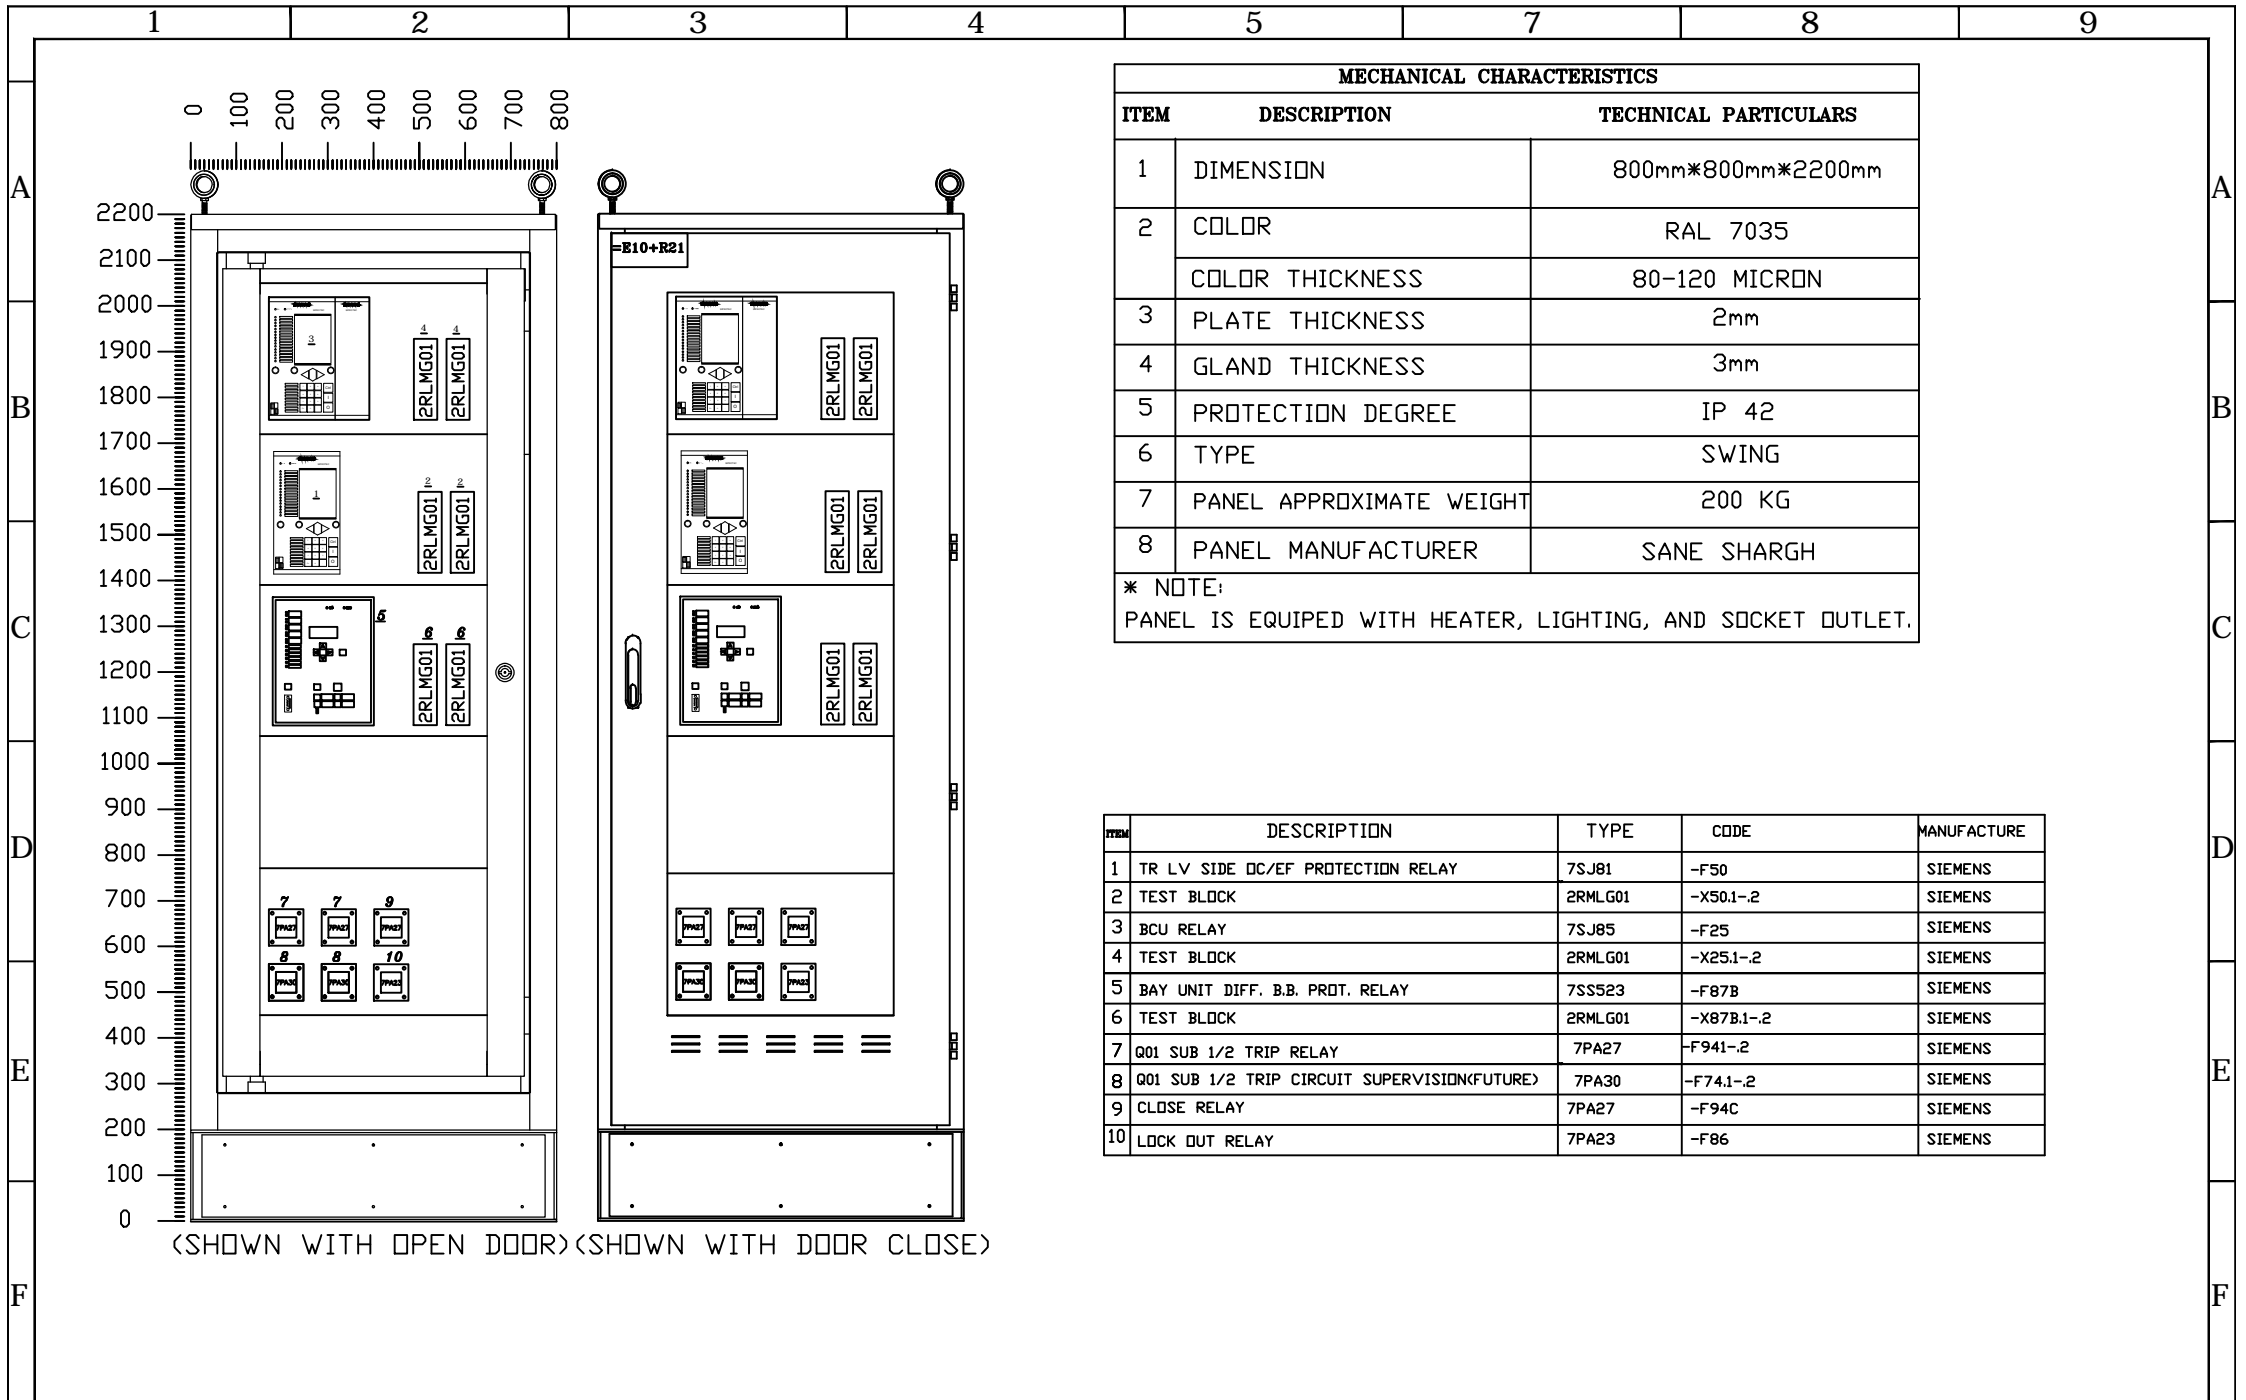

C			Consultant:	Client:	Contractor:		Name	Date	Title:	Project:	Scale: -
B							DESIGNED	SH.M	1402.05.20	FAJR.2	
A	FJR-MSC-MON-0036-2023/08/26	1402.06.14					DRAWN	SH.M	1402.05.20	400/132/KV GIS SUBSTATION	Size: A4
Z	FIRST ISSUE	1402.05.20	مونسکو ایران Monenco Iran	شرکت سانه شرج	MOHAM SHARGH COMPANY		CHECKED	A.DEHCHAN	1402.05.20	PROTECTION&METERING SINGLE LINE DIAGRAM	Sheet: 10
REV.	Description.	DATE					APPROVED	A.DEHCHAN	1402.05.20	Contract No:	Next Sheet: /